


- ALL PLUMBING IS TO BE TESTED IN ACCORDANCE WITH 2024 OBC 7.3.6. AND 7.3.7.
- ZONING HAS BEEN REVIEWED IN CONFORMITY WITH MINOR VARIANCE APPROVAL PLMNV20250024, THE TRANSITION PROVISIONS IN SECTION 18.9 OF BY-LAW 2024-100, AND THE R4-6 ZONE OF BY-LAW 3014.

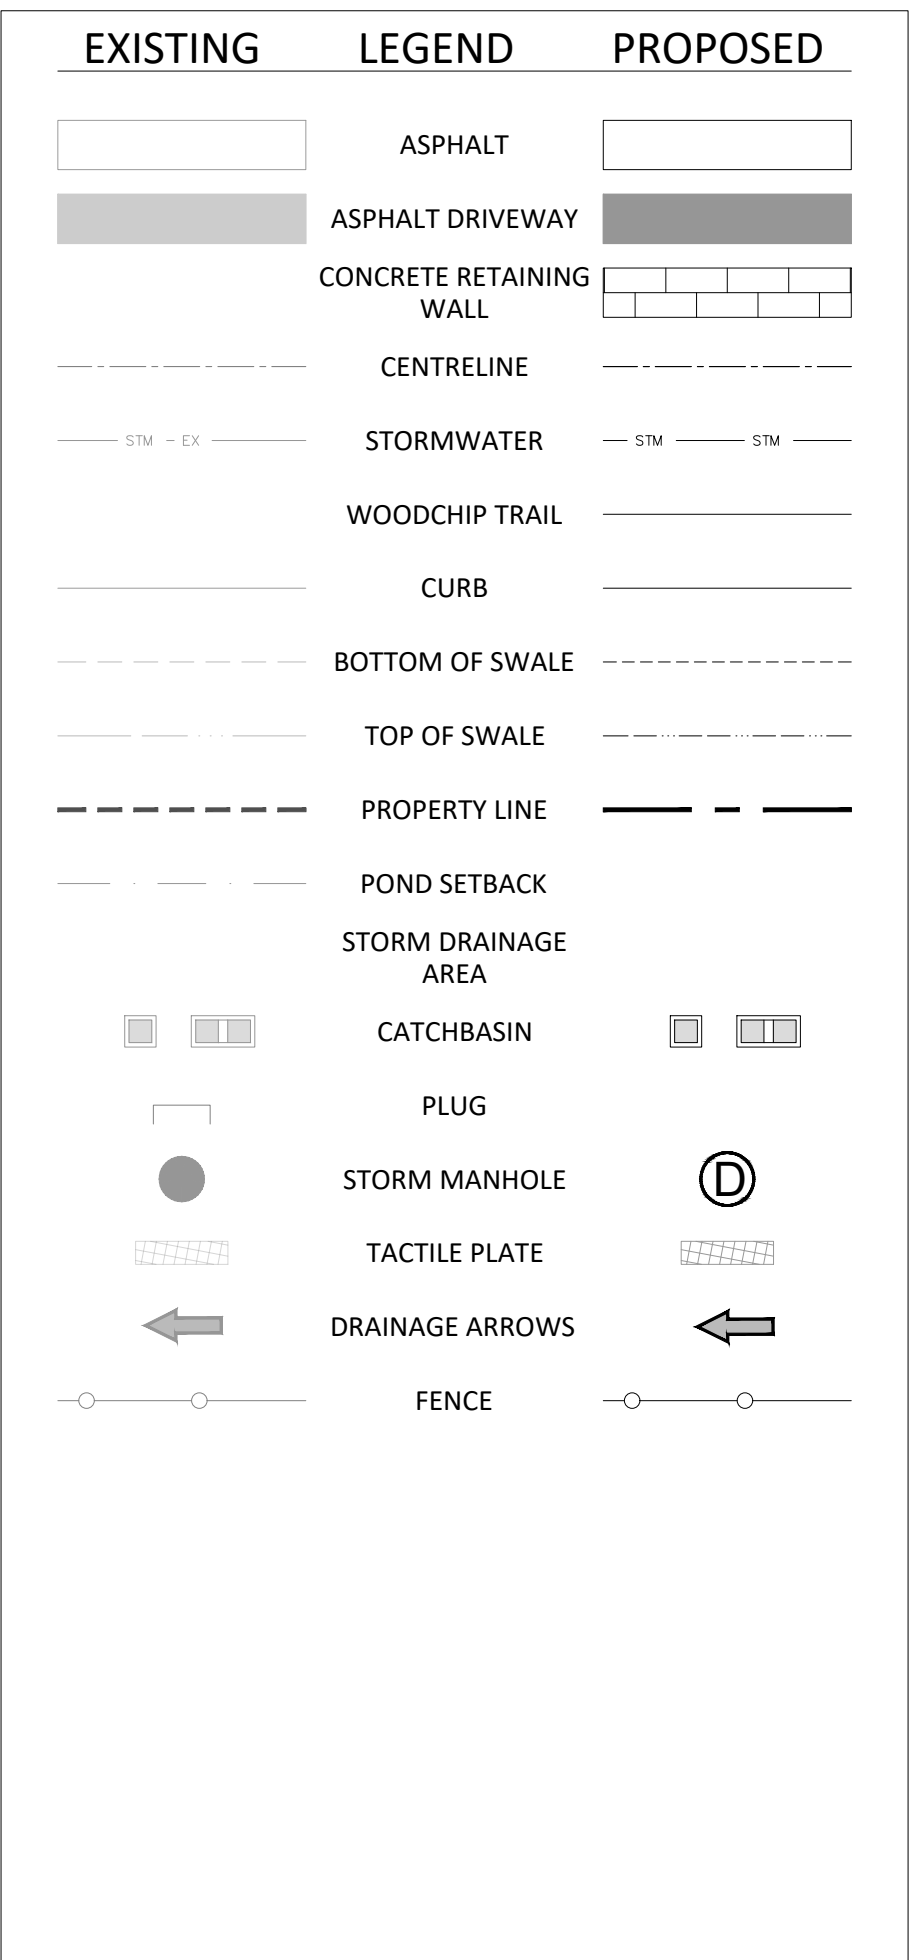

ENGINEER:
Steve Harvey, P.Eng

TITLE:
SITE PLAN

SCALE: 1:150	DATE: 2025/02/07	DRAWN: ACB, SJIC, ZAW, JDC, PPK	CHECKED: SGH
PROJECT NO: 24-278	REVISION: 005	DRAWING NO: SP	